


ELECTRICAL LEGEND	
⊕	SWITCH
⊕	THREE-WAY SWITCH
⊕	FOUR-WAY SWITCH
⊕	RECEPT
⊕	DUPLEX
⊕	COUNTERTOP DUPLEX
⊕	SPLIT WIRED DUPLEX
⊕	QUAD DUPLEX
⊕	CEILING DUPLEX
⊕	FLOOR DUPLEX
⊕	PHONE OUTLET
⊕	TV OUTLET
⊕	THERMOSTAT
⊕	SMOKE DETECTOR
⊕	JUNCTION
⊕	220 VOLT OUTLET
⊕	CEILING LIGHT
⊕	RECESSED CEILING LIGHT
⊕	WALL HUNG LIGHT
⊕	EYEBALL LIGHT
⊕	RECESSED EYEBALL LIGHT
⊕	VENT
⊕	VENT AND LIGHT
⊕	HEAT AND LIGHT
⊕	HEAT VENT AND LIGHT
⊕	LANDSCAPING LIGHT
⊕	FLOODLIGHT

NOT

ELECTRICAL
1ST FLOOR PLAN

SCALE: 1/8"=1'-0" 24x36 1/4"=1'-0"

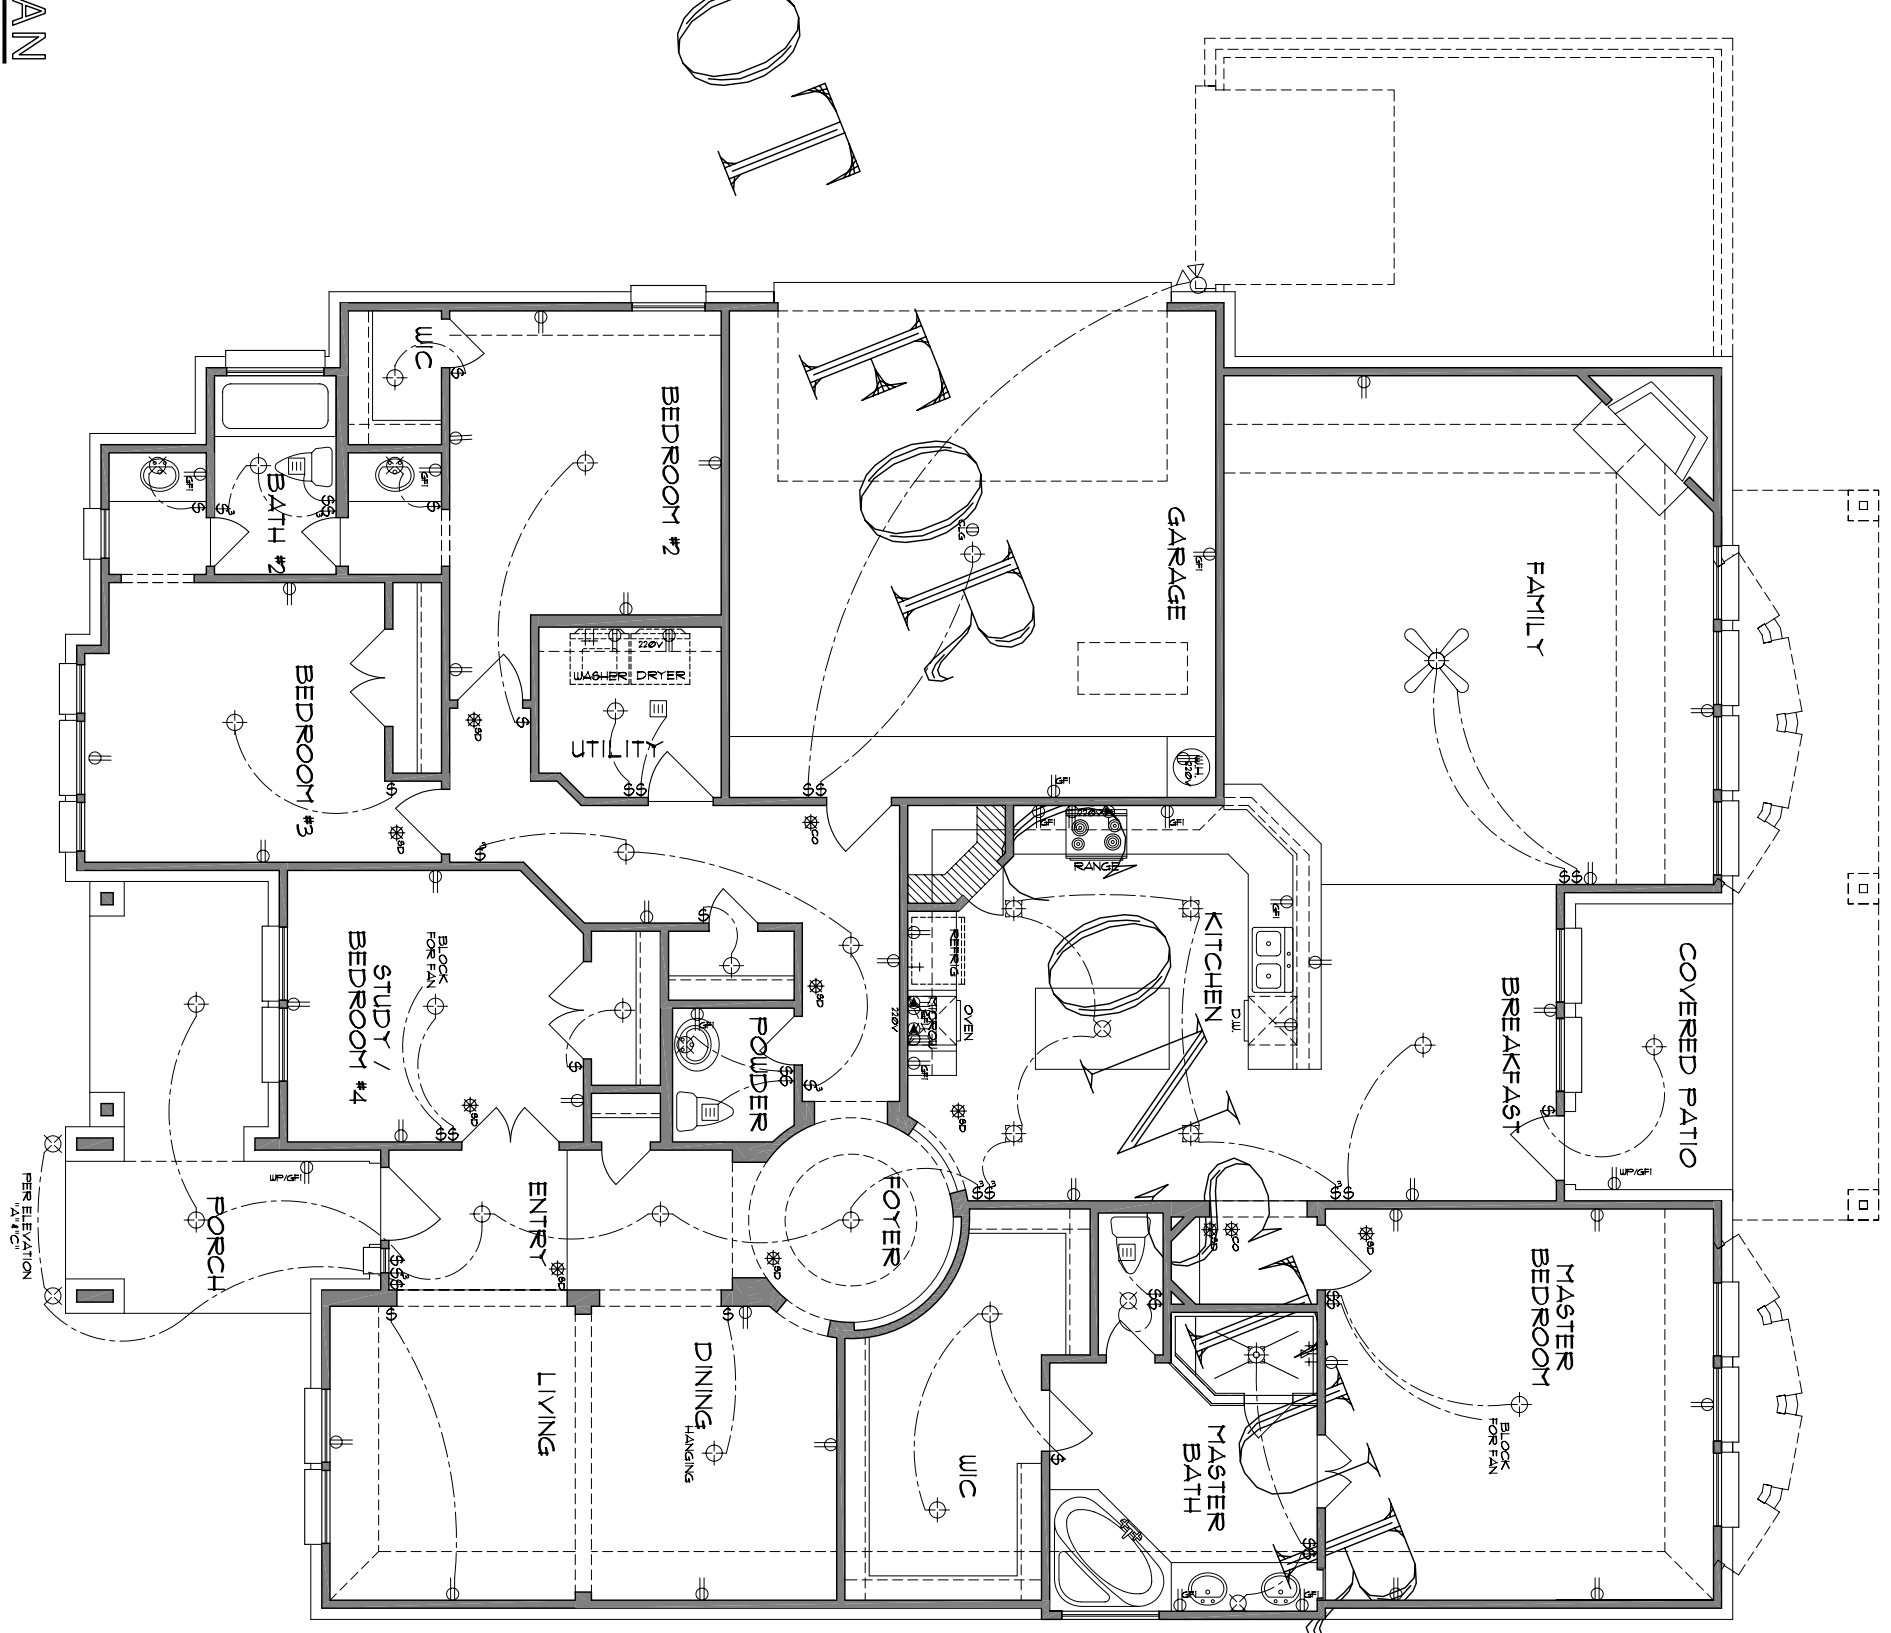

ATTENTION

PREPARED BY:



3401 CUSTER ROAD SUITE 116
PLANO, TX. 75023
PHONE: 972.943.1266
FAX: 972.943.1162
WWW.WORKINGDRAWINGS.NET

An architectural services company

PREPARED FOR:

REVISIONS:

11-15-06	REDLINES - JP
----------	---------------

PRECISION DRAWINGS reserves the right to make any changes to this drawing without notice. These drawings are intended to be used for construction purposes only. The contractor is responsible for verifying the accuracy of the information shown on these drawings. The architect is not responsible for the construction of the building or any other work shown on these drawings. The architect is not responsible for the construction of the building or any other work shown on these drawings. The architect is not responsible for the construction of the building or any other work shown on these drawings.

DATE:	06/11/06
DRAWN BY:	JAW
CHECKED BY:	ERY
DWG NO.	2875
PLAN NO.	2875

SHEET NO.

